



PROPOSED FIRST FLOOR PLAN

SCALE: 3/32" = 1'-0"

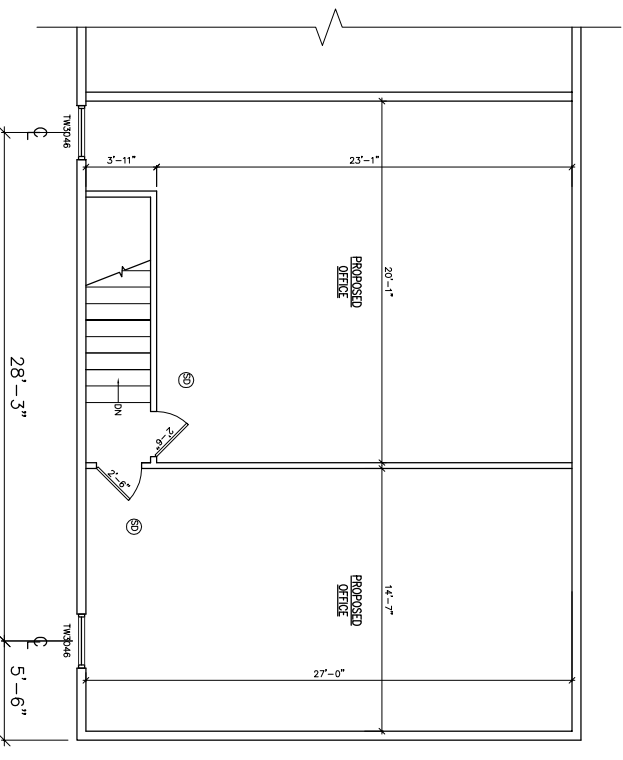

PROPOSED SECOND FLOOR PLAN (OFFICE)

SCALE: 3/32" = 1'-0"

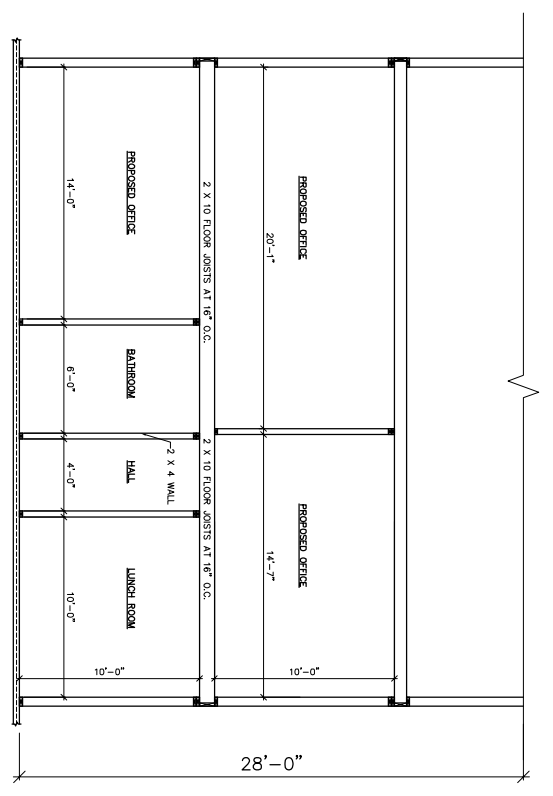

PROPOSED SECTION AT OFFICE

SCALE: 3/32" = 1'-0"

REVISIONS	DATE	BY	DESCRIPTION
1	3/3/2019	JMP	REVISED FOR ZBA
2	5/23/2019	JMP	REVISED FOR PLANNING BOARD COMMENTS

THIS SHEET IS INVALID AND VOID UNLESS ACCOMPANIED BY REMAINING SHEETS IN SET.

ENGINEER

TALCOTT ENGINEERING DESIGN PLLC
 1 GARONETOWN ROAD
 MARLBOROUGH, MA 01501
 (508) 552-4400
 (781) (943) -569-4583
 TALCOTTDESIGN@GMAIL.COM

PROPOSED FLOOR PLAN

ROYAL ENERGY PROPERTIES, LLC
 1666 ROUTE 9W
 SBL. 103.3-3-68, MILTON, NY 12847
 TOWN OF MARLBOROUGH, ULSTER COUNTY, NY

DATE: 12/27/2018
 SCALE: 3/32" = 1'-0"
 JOB NUMBER: 18224-LON
 SHEET NUMBER: 2 of 2

CHARLES T. BROWN, P.E.